


2.3

OPTION-1

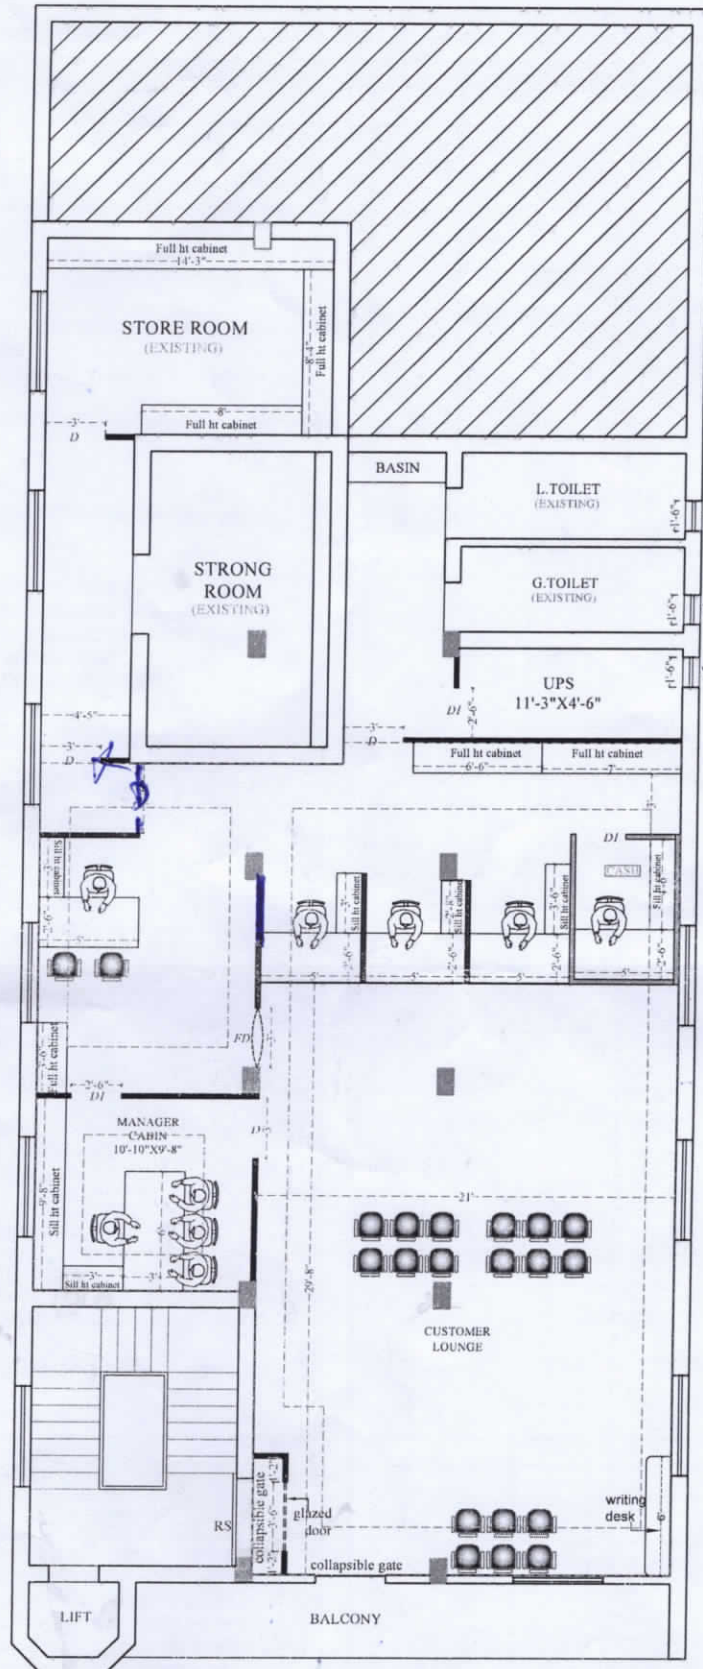

FIRST FLOOR PLAN

NOTES

- All dimensions to be read not to be scaled.
- This drawing supersedes all other previous drawings.
- Dimensions are in inches except otherwise.
- This drawing should be read in conjunction with relevant structural drawing and any discrepancy noticed should be got clarified before execution.
- The drawing is the property of the architects.
- Any copying or reproduction of this drawing should only be done after a written permission of the architects.
- Any defaulter is liable to be sued for the violation of the copyright act.

AREA CALCULATION :-

LEGEND :-

- FULL HT. PARTITION
- HALF HT. PARTITION
- CASH CAGE PARTITION

PROJECT

PROPOSED INTERIOR LAYOUT OF
BARTAND BRANCH

CLIENT

CANARA BANK

DRAWN BY

NORTH

CHECKED BY

Niraj Kumar



SCALE

Ar. Sunny Kumar

DATE

NOT TO SCALE

SHEET TITLE

22-05-24

02/24-15-24

DRAWING TITLE

(ID-1)

STAMP

ARCHITECT

VastuKriti

Jamshedpur, Patna

Mob: - 9905292793

email: - vastukriti108@gmail.com

email: - vastukriti326@gmail.com



architecture
interior
landscaping
planning


OPTION-1

Main electrical panel

Data Rack
CCTV
PDE

2 ton AC
AC24

1 ton AC
AC1

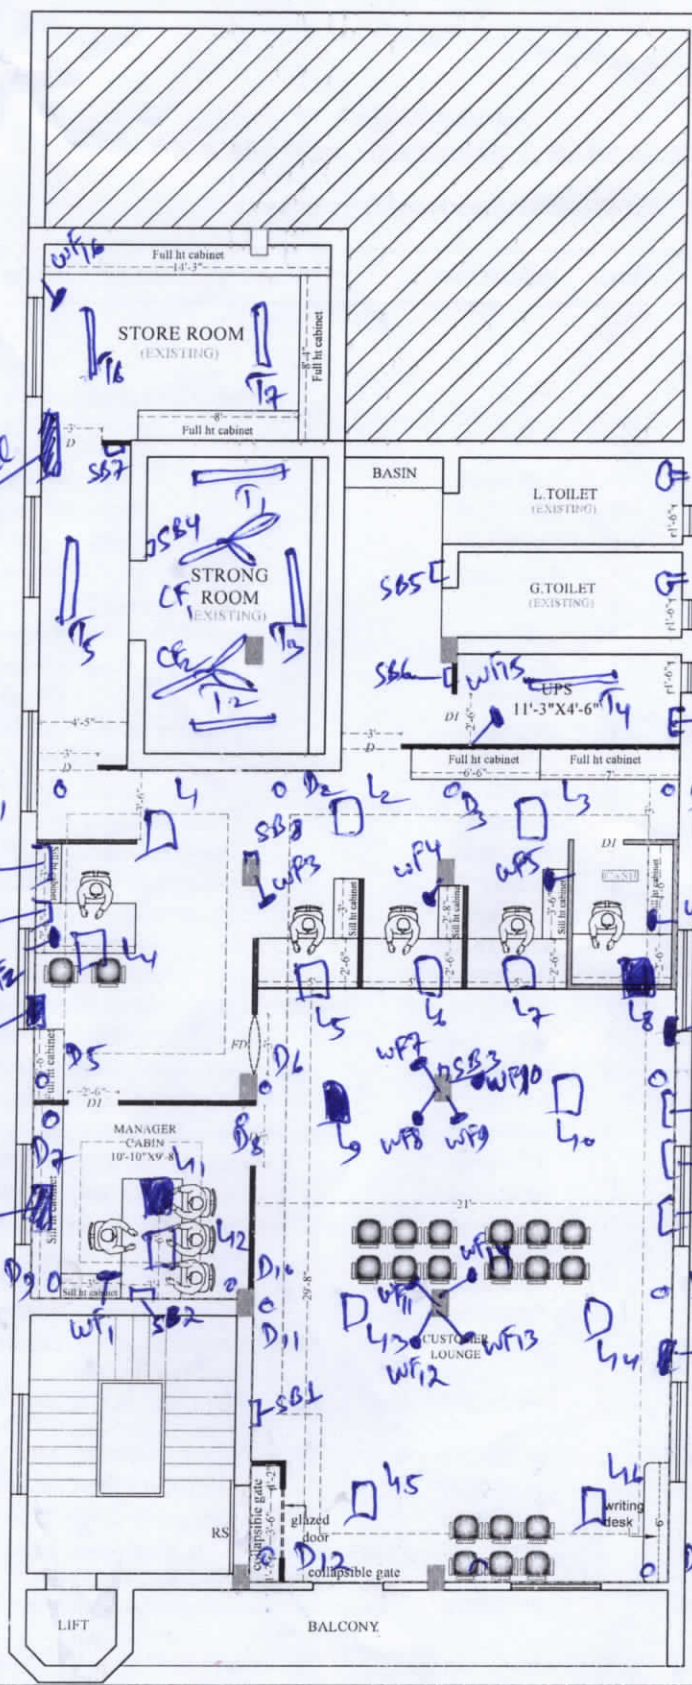

FIRST FLOOR PLAN

NOTES

- All dimensions to be read not to be scaled.
- This drawing supersedes all other previous drawings.
- Dimensions are in inches except otherwise.
- This drawing should be read in conjunction with relevant structural drawing and any discrepancy noticed should be got clarified before execution.
- The drawing is the property of the architects.
- Any copying or reproduction of this drawing should only be done after a written permission of the architects.
- Any defaulter is liable to be sued for the violation of the copyright act.

AREA CALCULATION:-

LEGEND:-

- FULL HT. PARTITION
- HALF HT. PARTITION
- CASH CAGE PARTITION

- SB1 to SB8 → Switch Boards
- L1 to L6 → 36w 2'x2' LED lights
- D1 to D15 → 12w LED downlighter
- T1, T2 → 22w LED Tubelighter
- B1, B2 → 12w LED Bulb
- E1, E2, E3 → Exhaust Fan
- CF1, CF2 → Ceiling Fan
- W1, W2 → wall mounted Fan
- 16 → UPS lights

PROJECT

PROPOSED INTERIOR LAYOUT OF BARTAND BRANCH

CLIENT

CANARA BANK

DRAWN BY

NORTH

CHECKED BY

Niraj Kumar

SCALE

NOT TO SCALE

DATE

22-05-24

SHEET TITLE

02/24-05-24

DRAWING TITLE

(ID-1)

STAMP

ARCHITECT

VastuKriti

Jamshedpur, Patna

Mob: - 9905292793

email: - vastukriti108@gmail.com

email: - vastukriti326@gmail.com



architecture
interior
landscaping
planning