


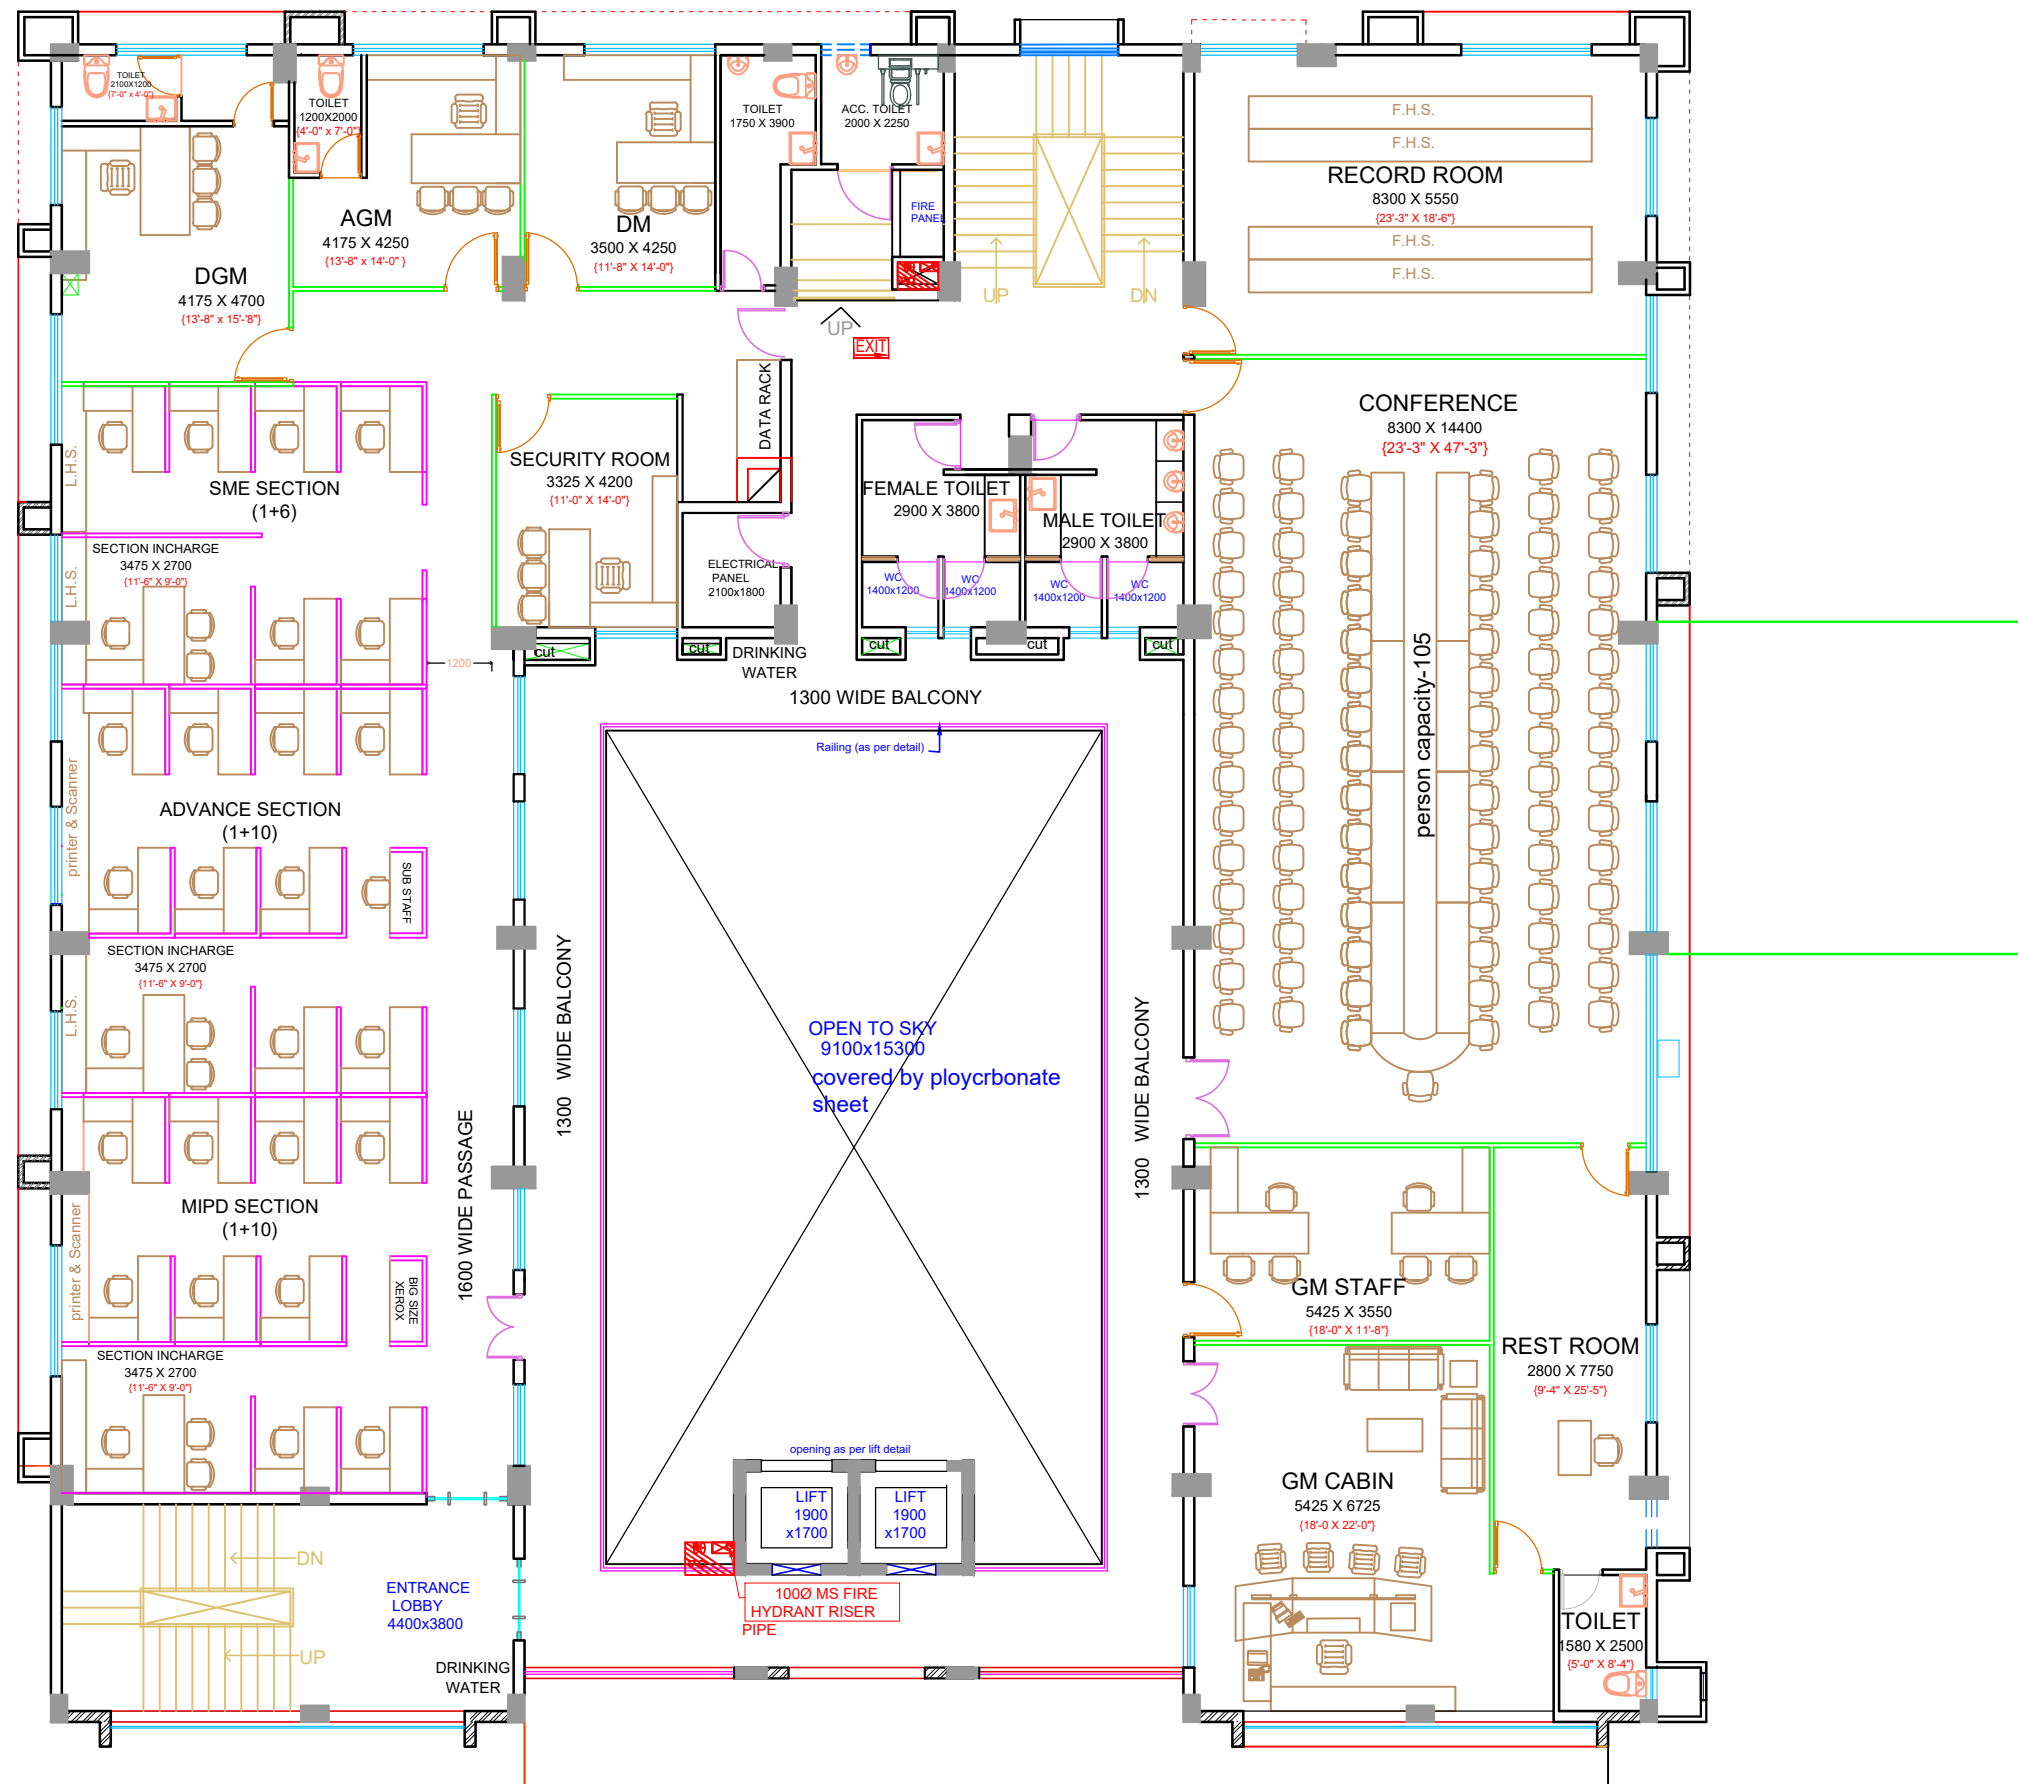


FIRST FLOOR PLAN

FULL HEIGHT PARTITION —————
LOW HEIGHT PARTITION —————

LEGEND FOR FIRE FIGHTING:-		
SYM.	DESCRIPTION	HEIGHT IN MM
	HOSE CABINET WITH 2 NOS. HOSE REEL & 1 NOS. BRANCH PIPES	-----
	100Ø WET RISER FOR HYDRANT & HOSE REEL	-----
	SPRINKLER	CEILING
	4.0 Kg. ABC FIRE EXTINGUISHER	1200
	4.5 Kg. CO2 FIRE EXTINGUISHER	1200
	FIRE EXIT SINGED BOARD	CEILING

NOTE:-
EACH FIRE HOSE CABINET
1 Nos. - GUNMETAL SINGLE HEADED HYDRANT
2 Nos. - FIRE HOSES 63mm 15M LONG WITH
1 Nos. - SHORT BRANCH
1 Nos. - FIRST AID HOSE REEL
2 Nos. - FIRE EXTINGUISHERS
1 Nos. - FIRE MAN'S AXE.

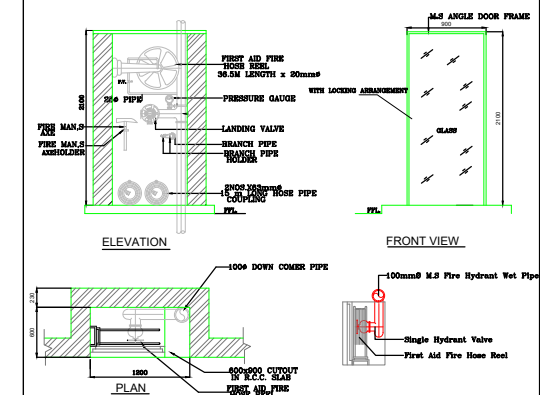

SPRINKLER PIPE SIZE:-	
NO. OF SPRINKLER	DIA OF PIPE
1-2	25Ø
3	32Ø
4-5	40Ø
6-10	50Ø
11-20	65Ø
21-30	80Ø
31-110	100Ø
111- ABOVE	150Ø

MEP Consultant:-
M.S ASSOCIATES
MEP CONSULTANT ENGINEERS
B-400, Gali No.-10, Veerbazar Road Near Krishna Dramsala, Gaurav Nagar, Prem Nagar Part-II, Nangloi, New Delhi-110086
E-Mail: msassociates95@gmail.com, ajay20051978@yahoo.com
Tel. 09213274289, 09555954522

ARCHITECTS
SHAIENDRA SHARMA ASSOCIATES
Architectural Consultancy Services
Bhopal office - A-105, janki nagar huna bhatti bhopal (m.p.)
Phone 408215, 9826026215
Email: ar.shailendrasharma@gmail.com

SHEET NO. SSA/CB/WD/WD/Base-01

PROJECT:- **PROPOSED CANARA BANK AT SAKET NAGAR, BHOPAL**

DRAWING TITLE :- FIRE FIGHTING LAYOUT PLAN (FIRST FLOOR PLAN)

DESIGN : R. RATHOR	
DRAWN : D. KUMAR	
CHECKED : A. KUMAR	
SCALE : N.T.S	
DATE : 28.09.2020	